


General Notes

No.	Revision/Issue	Date


Min. Name and Address
 MINISTRY OF WATER AND IRRIGATION
 KIRINYAGA EAST DISTRICT
 SURVEYED BY: NOKAN
 DESIGNED BY: GIBRAN J. MURITHI
 APPROVED BY: ENG M.K. THUITA

Project Name and Address
 KIINJOGA IRRIGATION
 WATER PROJECT



Sheet	Sheet
KIINJOGA CONVEYANCE	01/002-4/0100K-ZF
Date	21.12.2018
Scale	NOR 1:2000 VET 1:200

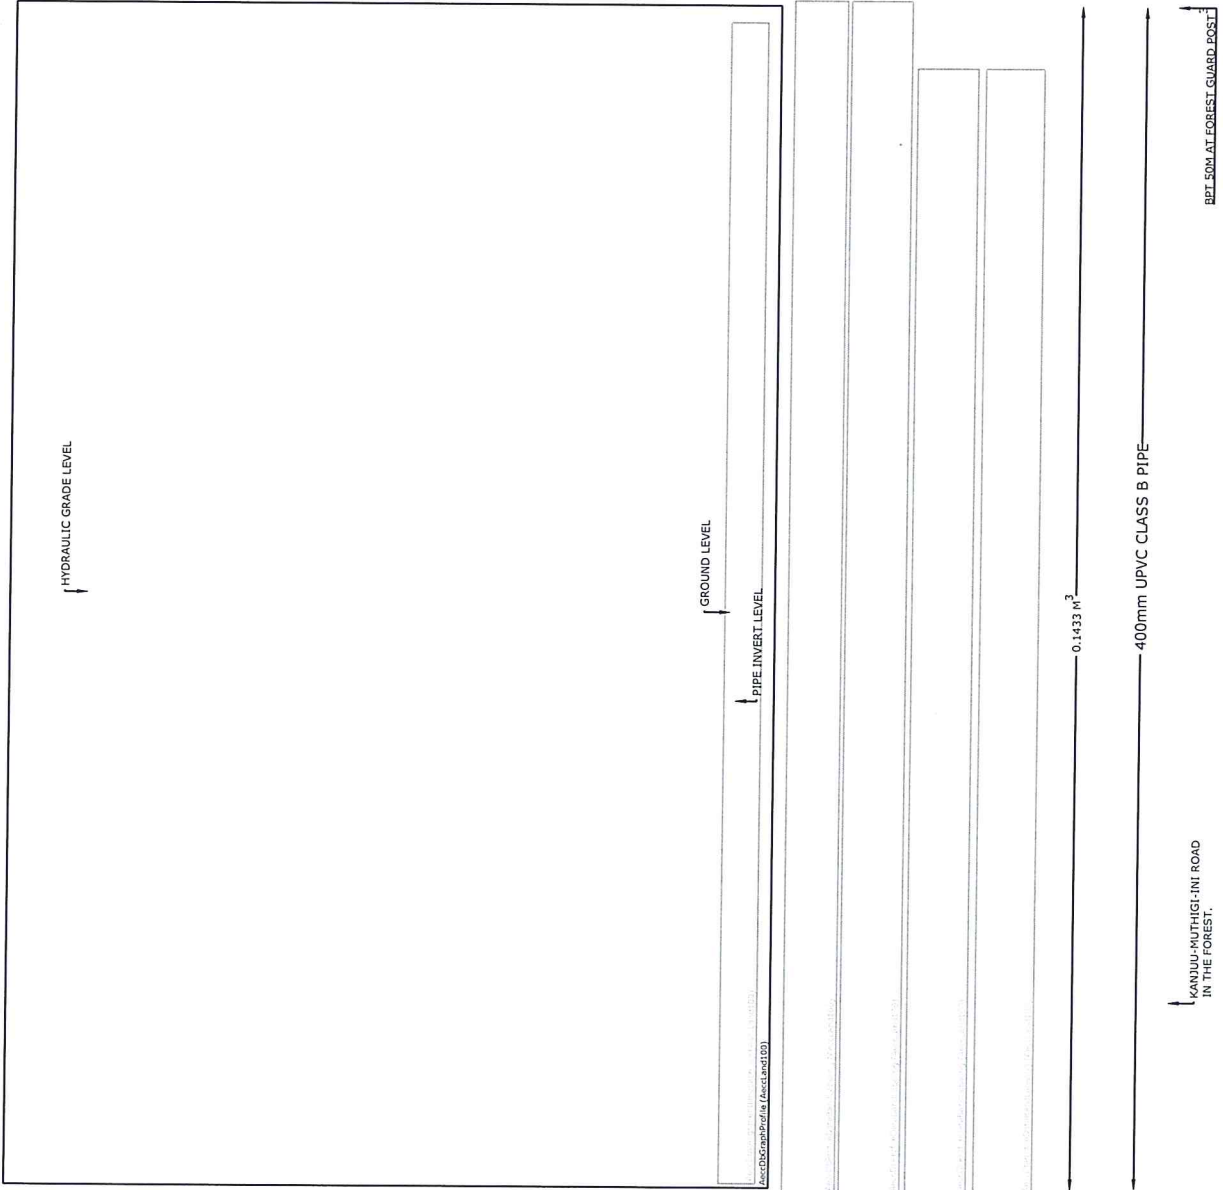




GATE VALVE INDICATOR POST
SCALE 1:10

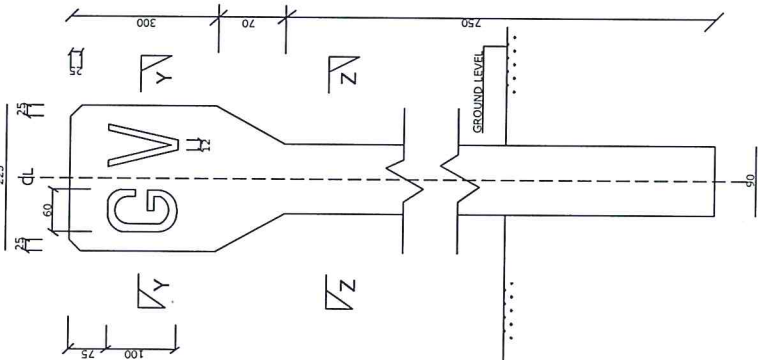

BULK METER POST
SCALE 1:10

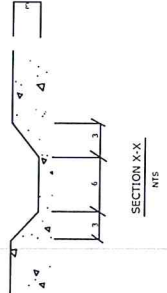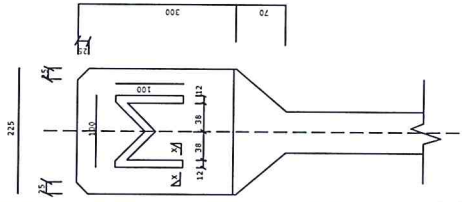

INDICATOR POST REINFORCEMENT DETAILS
SCALE 1:10

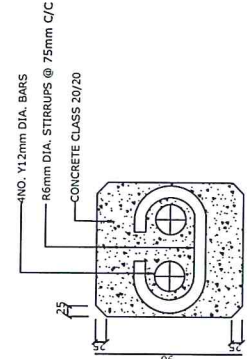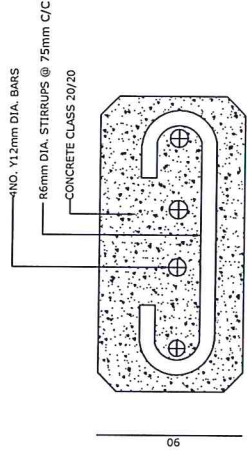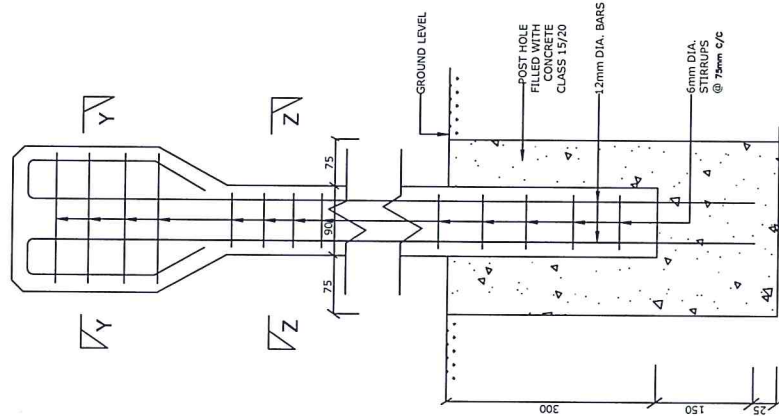

INDICATOR POST DETAILS

GENERAL NOTE

1. DIMENSIONS ARE SHOWN IN MILLIMETRES UNLESS OTHERWISE STATED

2. DETAILS FOR ALL INDICATOR POSTS TO BE AS FOR GATE VALVE BUT LETTERING TO BE AS FOLLOWS:

SCALE	INDICATOR POST
INDICATOR POST	INDICATOR POST
AIR VALVE	AIR VALVE
WASCOPT	WASCOPT
BULK METER	BULK METER
INDICATOR POST	INDICATOR POST

3. ALL INDICATOR POSTS TO BE PAINTED WITH 2 COATS BLUE OIL BASED PAINT AND WHITE LETTERING TO ENGINEER'S APPROVAL.

ABBREVIATIONS

MM - MILLIMETRE
O.D. - OUTSIDE DIAMETER
NO. - NOMINAL DIAMETER
C/C - CENTRE TO CENTRE
MPC - UNPLASTICISED POLYVINYL CHLORIDE
C - CENTRE
G.V. - GATE VALVE
W.O. - WASH OUT
M.P. - METER
M - METER
M³ - CUBIC METER

NO.	REVISION	DATE

FIRM NAME AND ADDRESS

MINISTRY OF WATER AND IRRIGATION
NYERI COUNTY

PROJECT NAME AND ADDRESS

STANDARD DRAWINGS
INDICATOR POST DETAILS

PROJECT		DRG NO.
NGERWE RUPINGAZI		
DATE	15/06/2012	03/NRP-E/NGERWE-3
SCALE	1:100	